


Station 7 leak in highlighted area

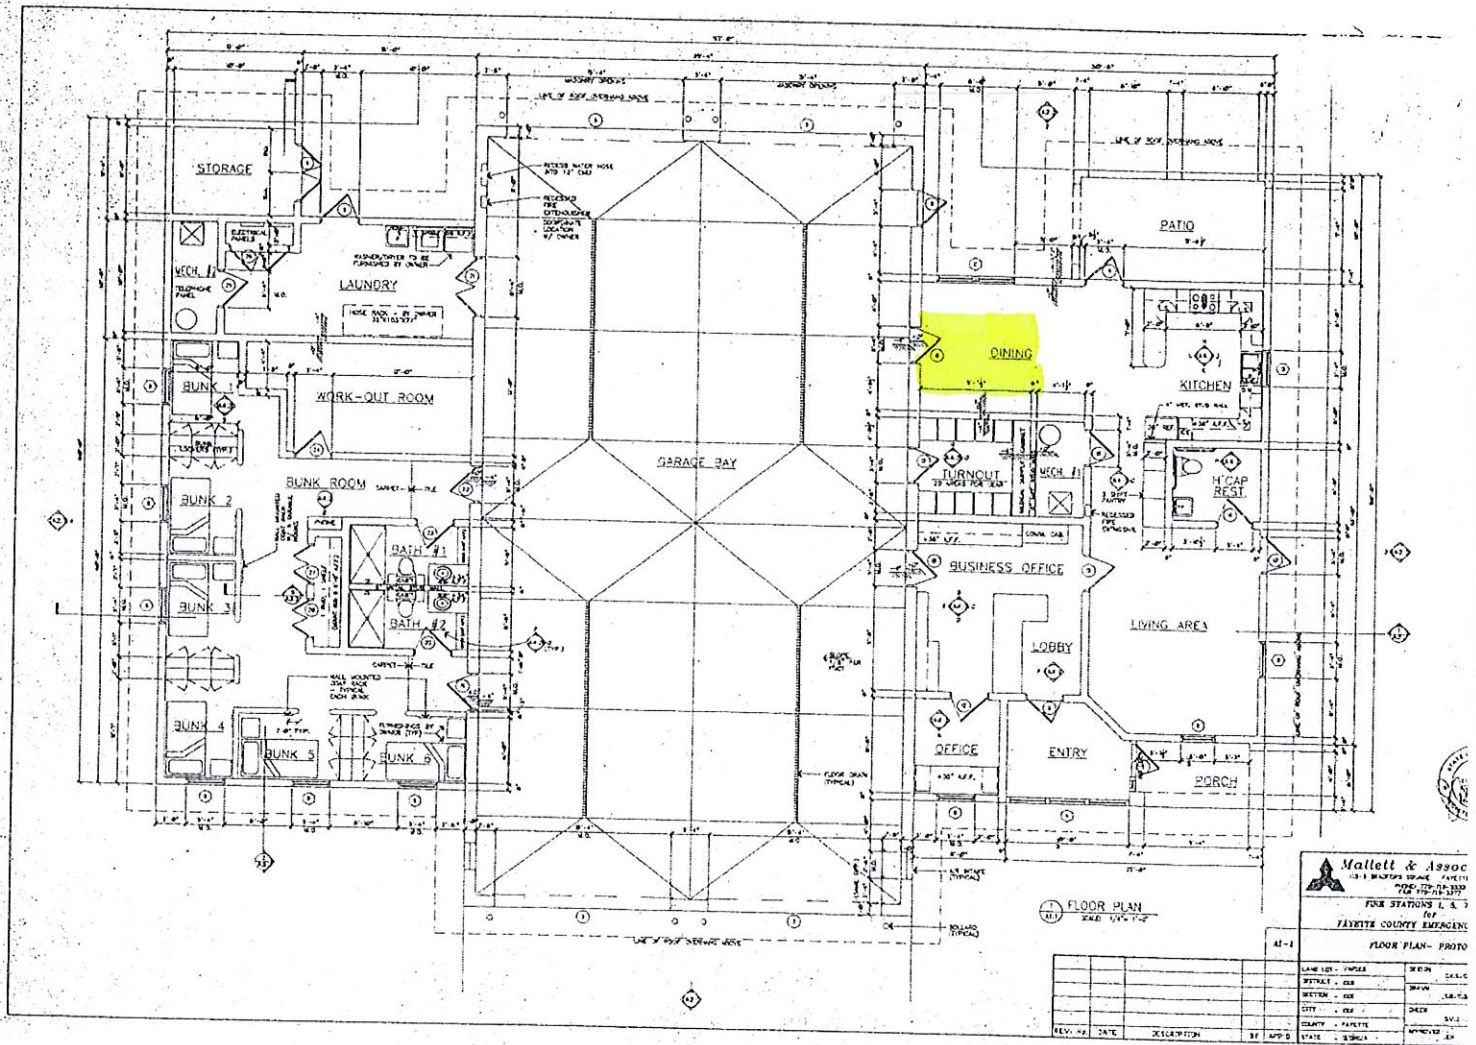


FLOOR PLAN
SCALE 1/4" = 1'-0"

Mallett & Assoc
1213 W. BROADWAY, SUITE 100
FAIRFAX, VA 22031
PHONE (703) 271-1100
FAX (703) 271-1101

AL-1

REV. NO.	DATE	DESCRIPTION	BY	APP'D	STATE	REGISTERED

Station 1 leak in highlighted area

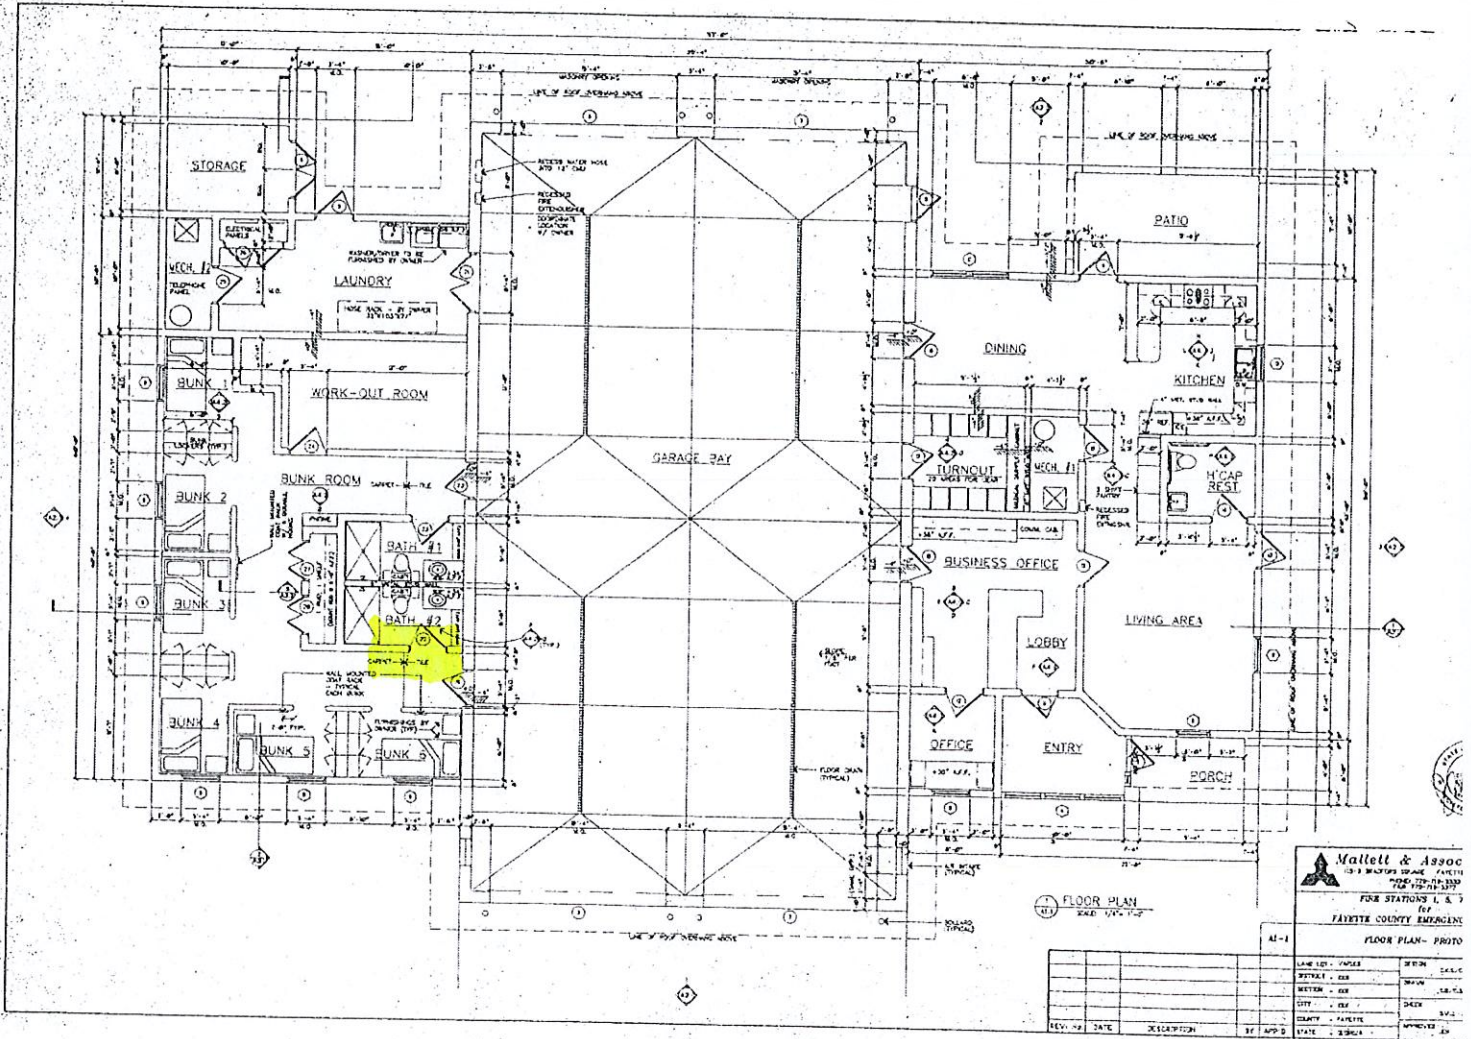


FLOOR PLAN
SCALE 1/8" = 1'-0"

Mattell & Assoc
 1213 S. BRADLEY BLVD. FAIRFAX, VA 22031
 (703) 727-1133
 FAX (703) 727-1134
 101
FAIRFAX COUNTY EMERGENCY
 FLOOR PLAN - PHOTO

REV. NO.	DATE	DESCRIPTION	BY	APP'D	STATE	DATE

Station 6 leak in highlighted area

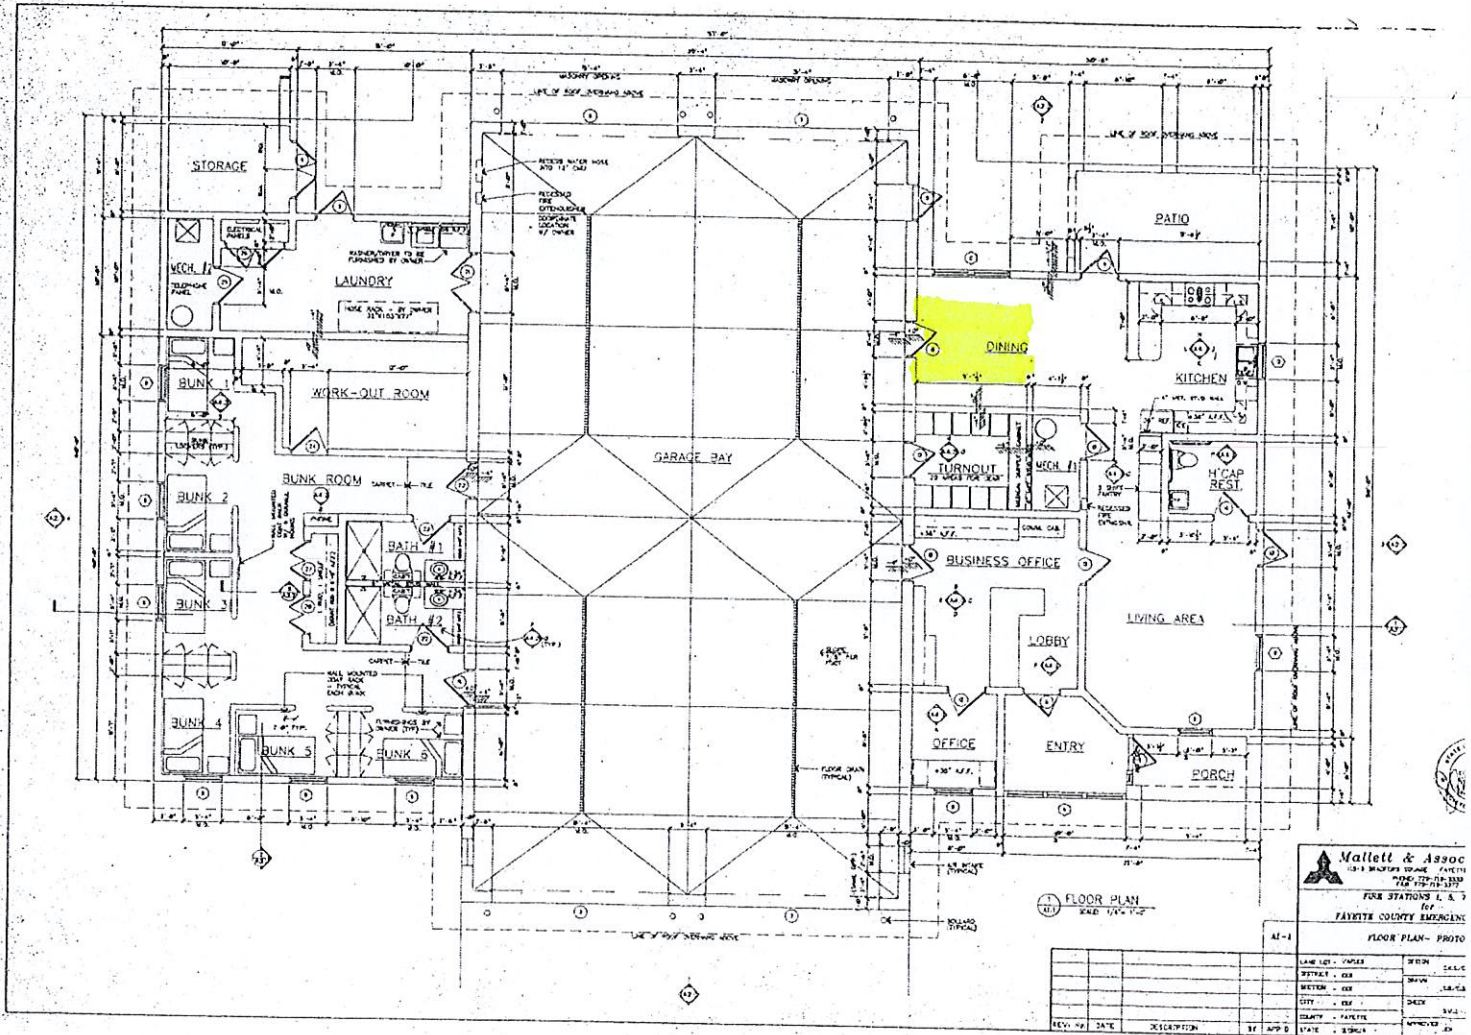

Mallett & Assoc
 1214 W. 10TH ST. FAIRFIELD, CA 94504
 (916) 433-1111
 FOR
FAIRFAX COUNTY EMERGENCY
 FLOOR PLAN - PHOTO

REV. NO.	DATE	DESCRIPTION	BY	APP'D	STATE	REG. NO.

